


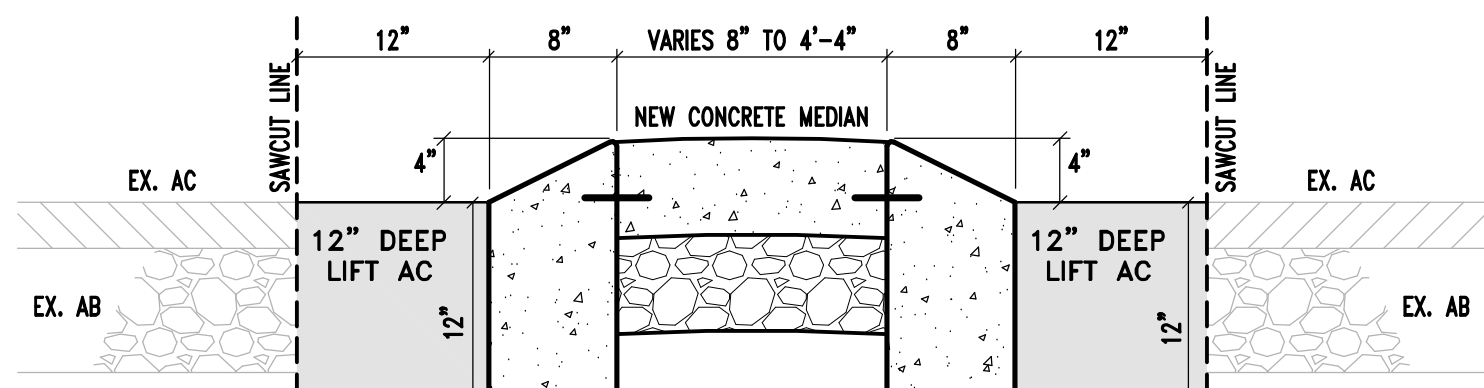


NOTE:
PROVIDE DEEP JOINTS EVERY
10' ACROSS CONCRETE AND
CURB. PLACE ADDITIONAL SCORE
MARKS EVERY 5' ON CONCRETE

MEDIAN ISLAND WITH
MOUNTABLE CURB
NOT TO SCALE

EXISTING BUILDING:	19,344 SQ. FT.
NEW ADDITION:	14,473 SQ. FT.
NEW BASEMENT:	6,905 SQ. FT.
TOTAL:	40,722 SQ. FT.

PROPOSED PARKING PROVIDED

ON-SITE PARKING:	
ACCESSIBLE STALLS:	4
STANDARD STALLS:	75
COMPACT:	13
TOTAL:	92
ON-STREET PARKING:	8

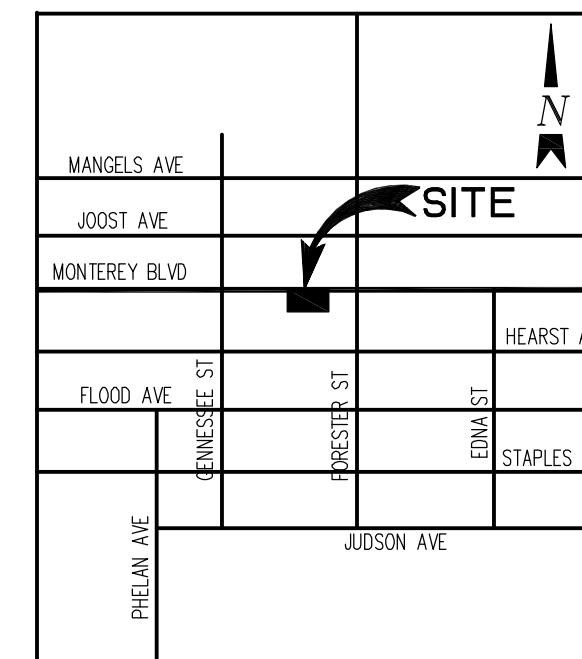


VICINITY MAP
NTS

KEY NOTES

- EXISTING FIRE HYDRANT TO REMAIN
- EXISTING DRIVEWAY TO BE REMOVED
- REMOVE PORTION OF EXISTING MEDIAN ISLAND AND CONSTRUCT NEW MEDIAN ISLAND WITH MOUNTABLE CURB
- EXISTING TREE TO REMAIN
- EXISTING SIDEWALK TO BE REPLACED WITH CITY STANDARD SIDEWALK
- EXISTING DRIVEWAY TO BE MODIFIED
- EXISTING BELOW GRADE ELECTRICAL VAULT TO REMAIN
- PROPOSED DECORATIVE RAILING
- NEW FIRE SPRINKLER RISER
- CARTONICS (CART SECURITY) ACROSS DRIVEWAY
- PROPOSED BELOW GRADE TRANSFORMER
- EXISTING TREE TO BE REMOVED
- NEW MEDIAN ISLAND WITH MOUNTABLE CURB
- NEW MEDIAN ISLAND WITH LANDSCAPING



0 10 20 40 60
Scale 1" = 20 ft

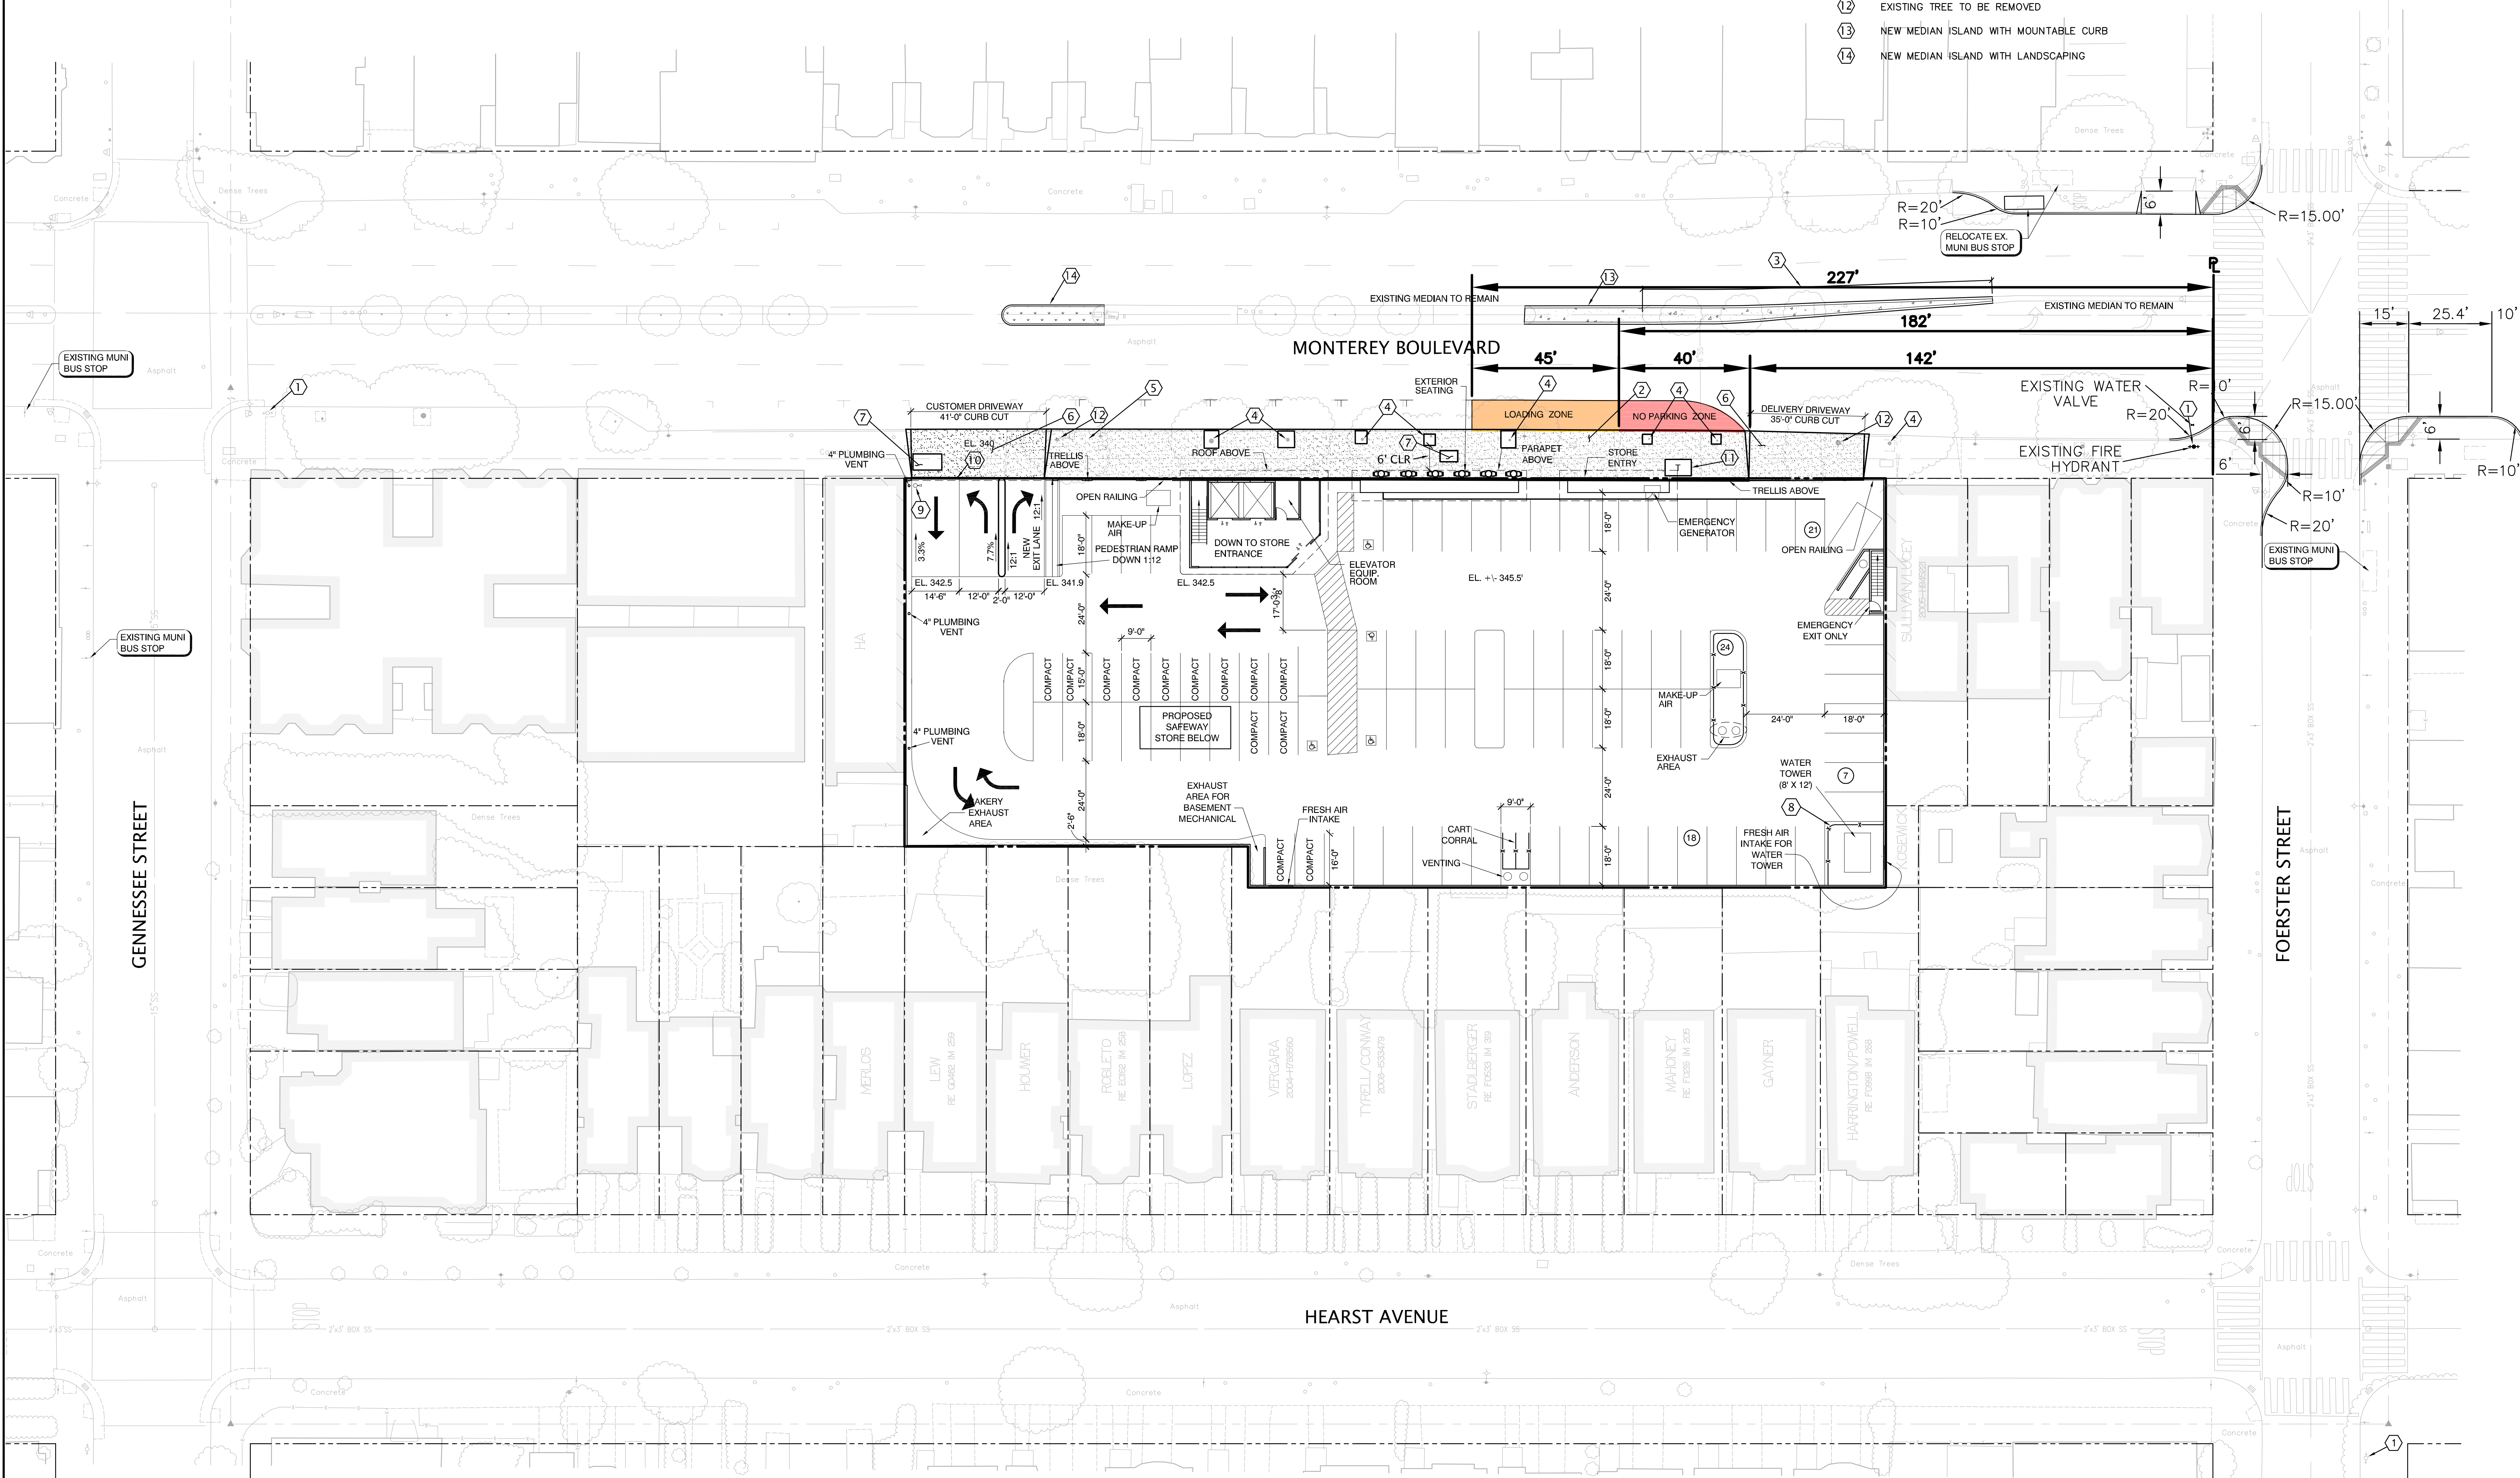

STORE EXPANSION

KIER & WRIGHT
CIVIL ENGINEERS & SURVEYORS, INC.
2850 Collier Canyon Blvd.
Livermore, California 94551
PH (925) 245-8788
Fax (925) 245-8796

SAFeway
NORCAL DIVISION
5918 STONERIDGE MALL ROAD, PLEASANTON, CA 94586-3229

SAFeway STORE 0759
SAN FRANCISCO, CA
25-2983-0000
625 MONTEREY BLVD.

DATE	DESCRIPTION
07/17/2013	REVISED MEDIAN ISLAND AND LANDSCAPING
05/09/2013	ADDED DIMENSIONS TO BUILDINGS, NO PARKING
05/02/2013	REVISED SITE PLAN, MEDIAN AND BUILDINGS

DATE:	09-17-2009
JOB NO.:	A08663-2
DRAWN BY:	KAS
DESIGNER:	SC
CHECKED BY:	SC

SHEET TITLE
CONCEPTUAL
SITE PLAN
ROOF LEVEL

SHEET NO.
C3